
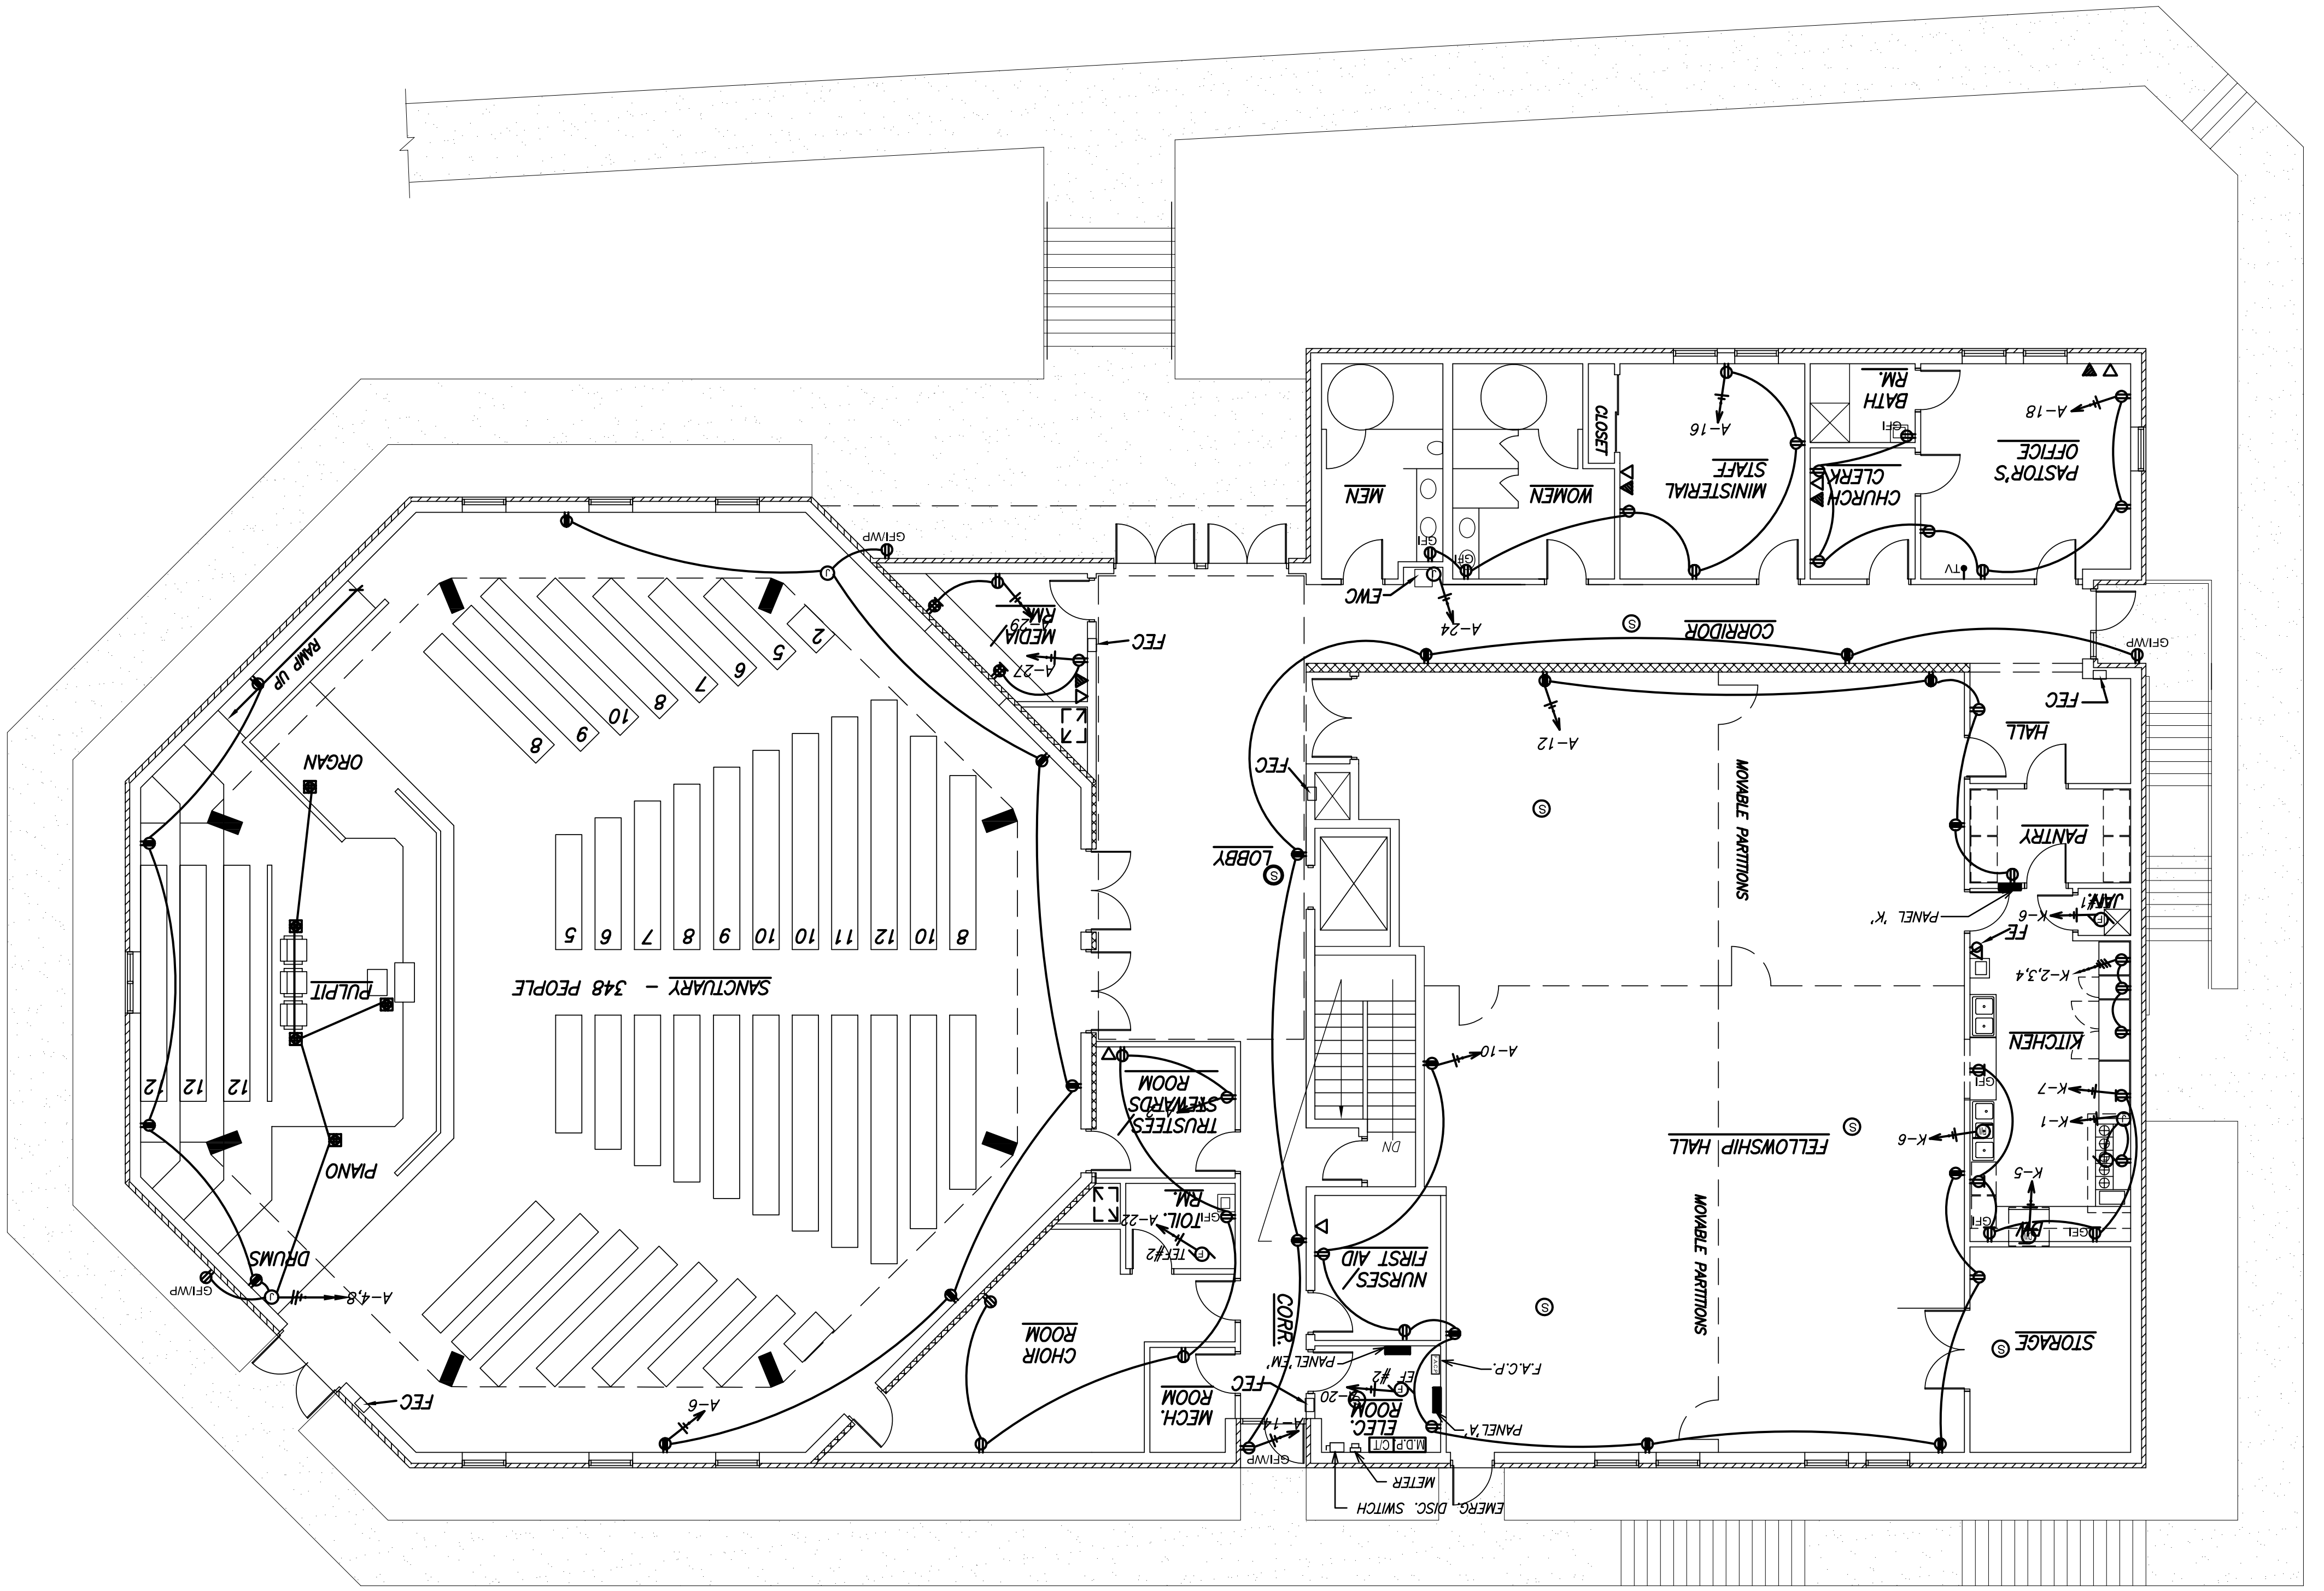



GROUND FLOOR PLAN - POWER & COMMUNICATION
SCALE: 1/8"=1'-0"

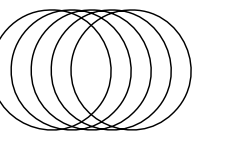

- SYMBOL LEGEND**
- - DUPLEX RECEPTACLE OUTLET, NEMA 5-20R, TAMPER PROOF, 18" A.F.F.
 - - QUID RECEPTACLE OUTLET, NEMA 5-20R, 18" A.F.F.
 - - DUPLEX RECEPTACLE OUTLET, NEMA 5-20R, TABLE TOP
 - - DUPLEX RECEPTACLE OUTLET, NEMA 5-20R, 44" A.F.F.
 - - DUPLEX RECEPTACLE OUTLET W/ROUND FAULT INTERRUPTER, NEMA 5-20R
 - - W/ROUND FAULT INTERRUPTER, (NEMA 5-20R)
 - - DUPLEX RECEPTACLE OUTLET (20A, 2P, 220 VOLT)
 - - QUID RECEPTACLE OUTLET, FLR, WTD.
 - - JUNCTION BOX
 - - PANELBOARD
 - ⊖ - EXHAUST FAN CONNECTION
 - ⊖ - DISHWASHER
 - ⊖ - FOOD WASTE DISPOSAL
 - ▽ - TELEPHONE OUTLET, 18" A.F.F.
 - ▲ - DATA OUTLET 18" AFF, PROVIDE JUNCTION BOX AND CONDUIT TO CEILING SPACE, TERMINATE BY OTHERS.
 - ⊖ - TELEVISION OUTLET
 - ⊖ - BRANCH CIRCUIT HANGERS TO PANELBOARD, NUMBER OF ARROWS INDICATES NUMBER OF CIRCUITS, FULL SLASHES INDICATE UNGROUND "HOT" CONDUCTORS, HALF SLASHES INDICATE GROUND NEUTRAL CONDUCTOR(S), DOT INDICATES EQUIPMENT GROUNDING CONDUCTOR
 - ⊖ - SLASHES INDICATE ONE "HOT", ONE NEUTRAL AND EQUIPMENT GROUNDING CONDUCTORS.

Drawing No. E-4 of -	
Date: NOV. 29, 2005 Scale: 1/8"=1'-0" Drawn: PAL Checked: C.FORD File No. BETH_A01	
Philip Aaron Lacy, Architect 4013 21st. Place Temple Hills, Maryland 20748 Phone: 301-894-7979	
	
Project Title: BETH SHALOM A.M.E. ZION CHURCH 2501 RITCHIE ROAD DISTRICT HEIGHTS, MARYLAND 20735 GROUND FLOOR PLAN - POWER/COMMUNICATION	
Certification:	
Engineers:  CHARLES FORD & ASSOCIATES CONSULTING - ENGINEERS & PLANNERS 4425 GEORGETOWN AVE., N.W. WASH., D.C. (202) 772-4190	
Revisions:	
① PERMIT ② PERMIT A PERMIT	Date: 10-3-07 07-8-08 11/06/08