




**1** LOWER LEVEL PLAN  
MP.1 SCALE: 1/4" = 1'-0"

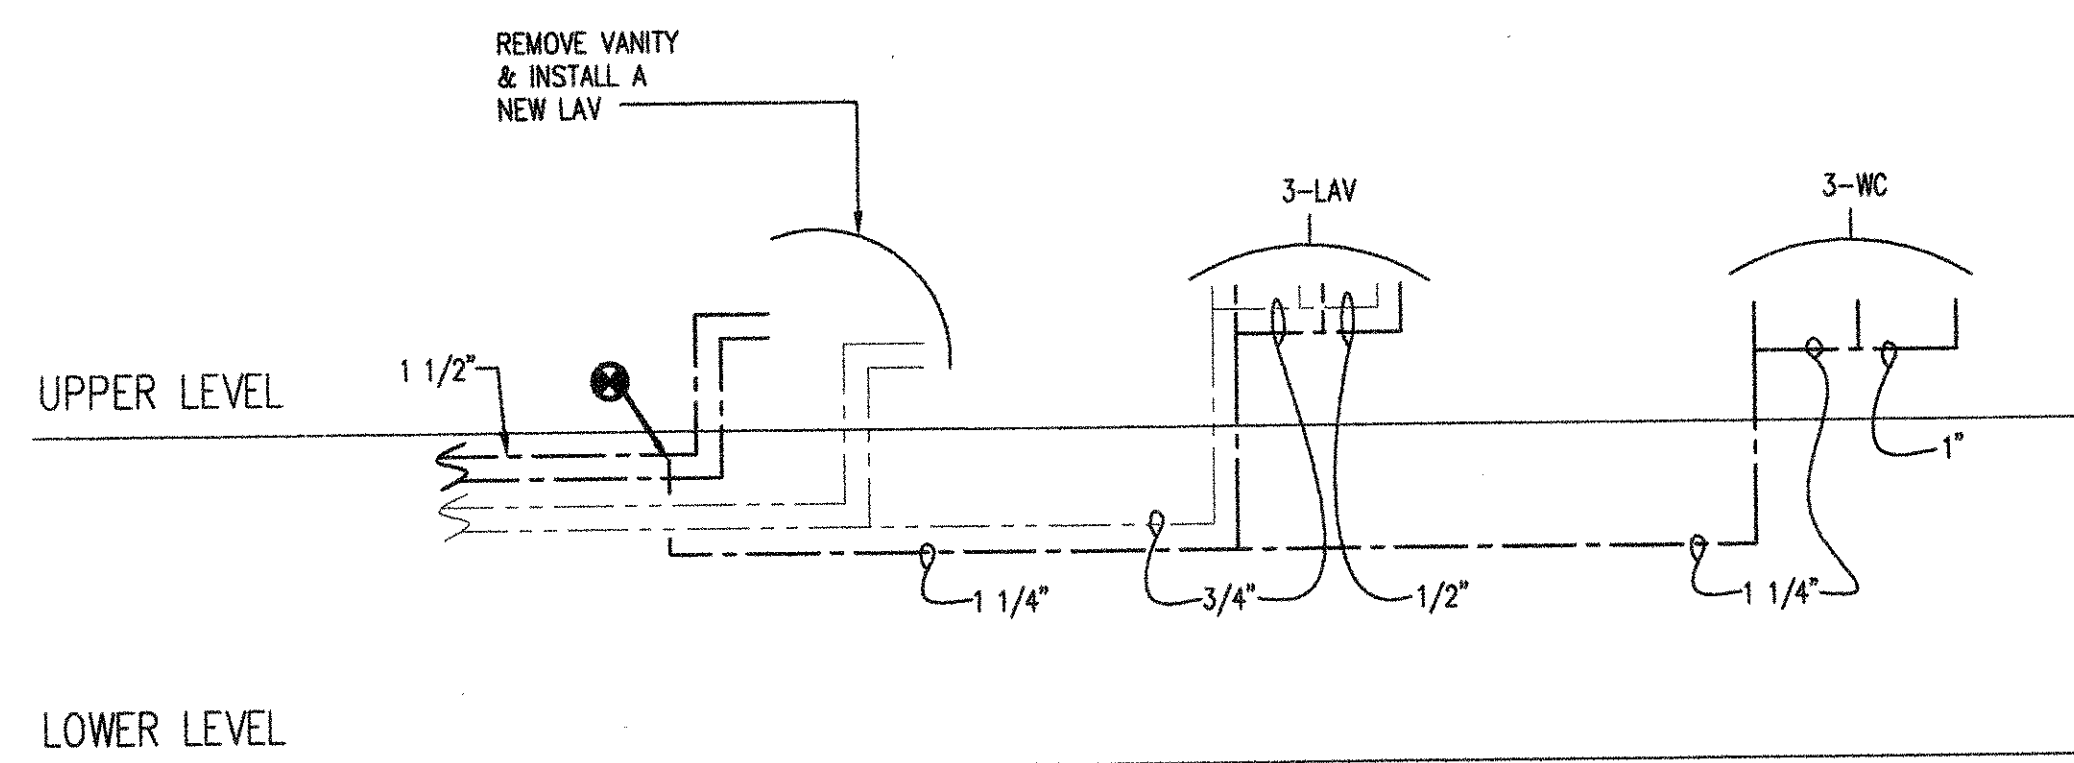

**DRAINAGE DIAGRAM**  
NOT TO SCALE

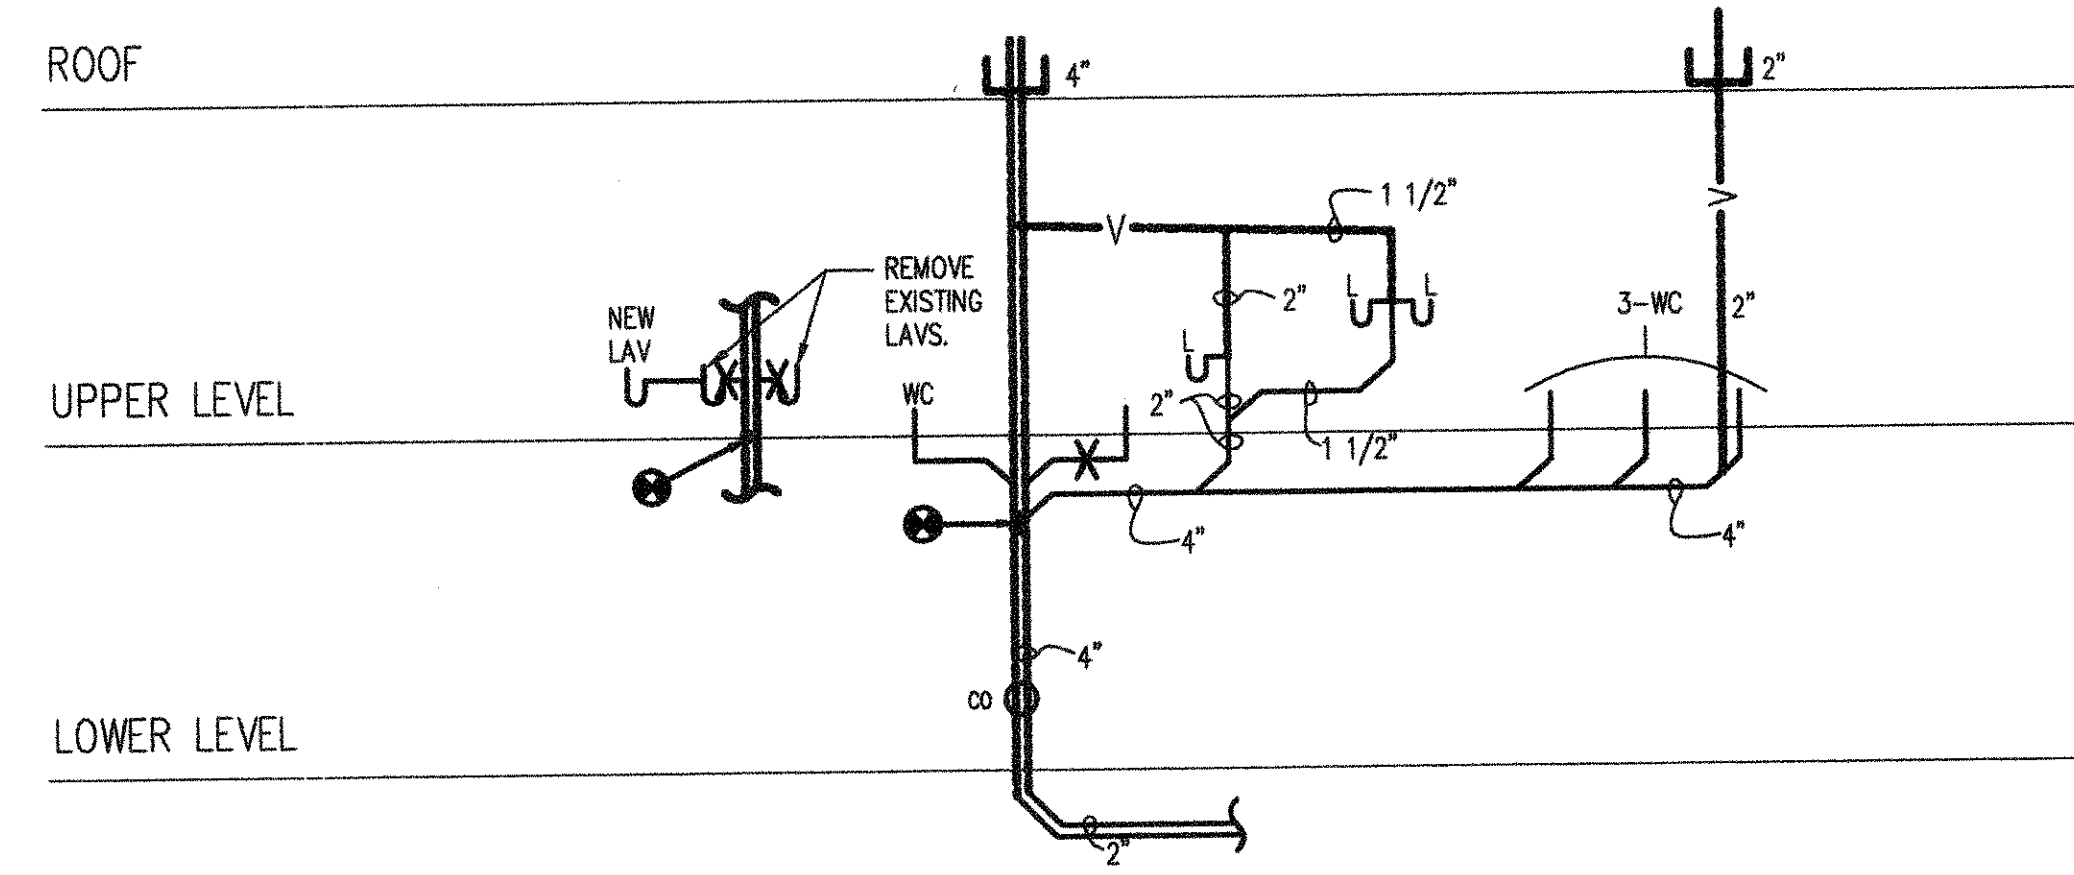

**WATER RISER DIAGRAM**  
NOT TO SCALE

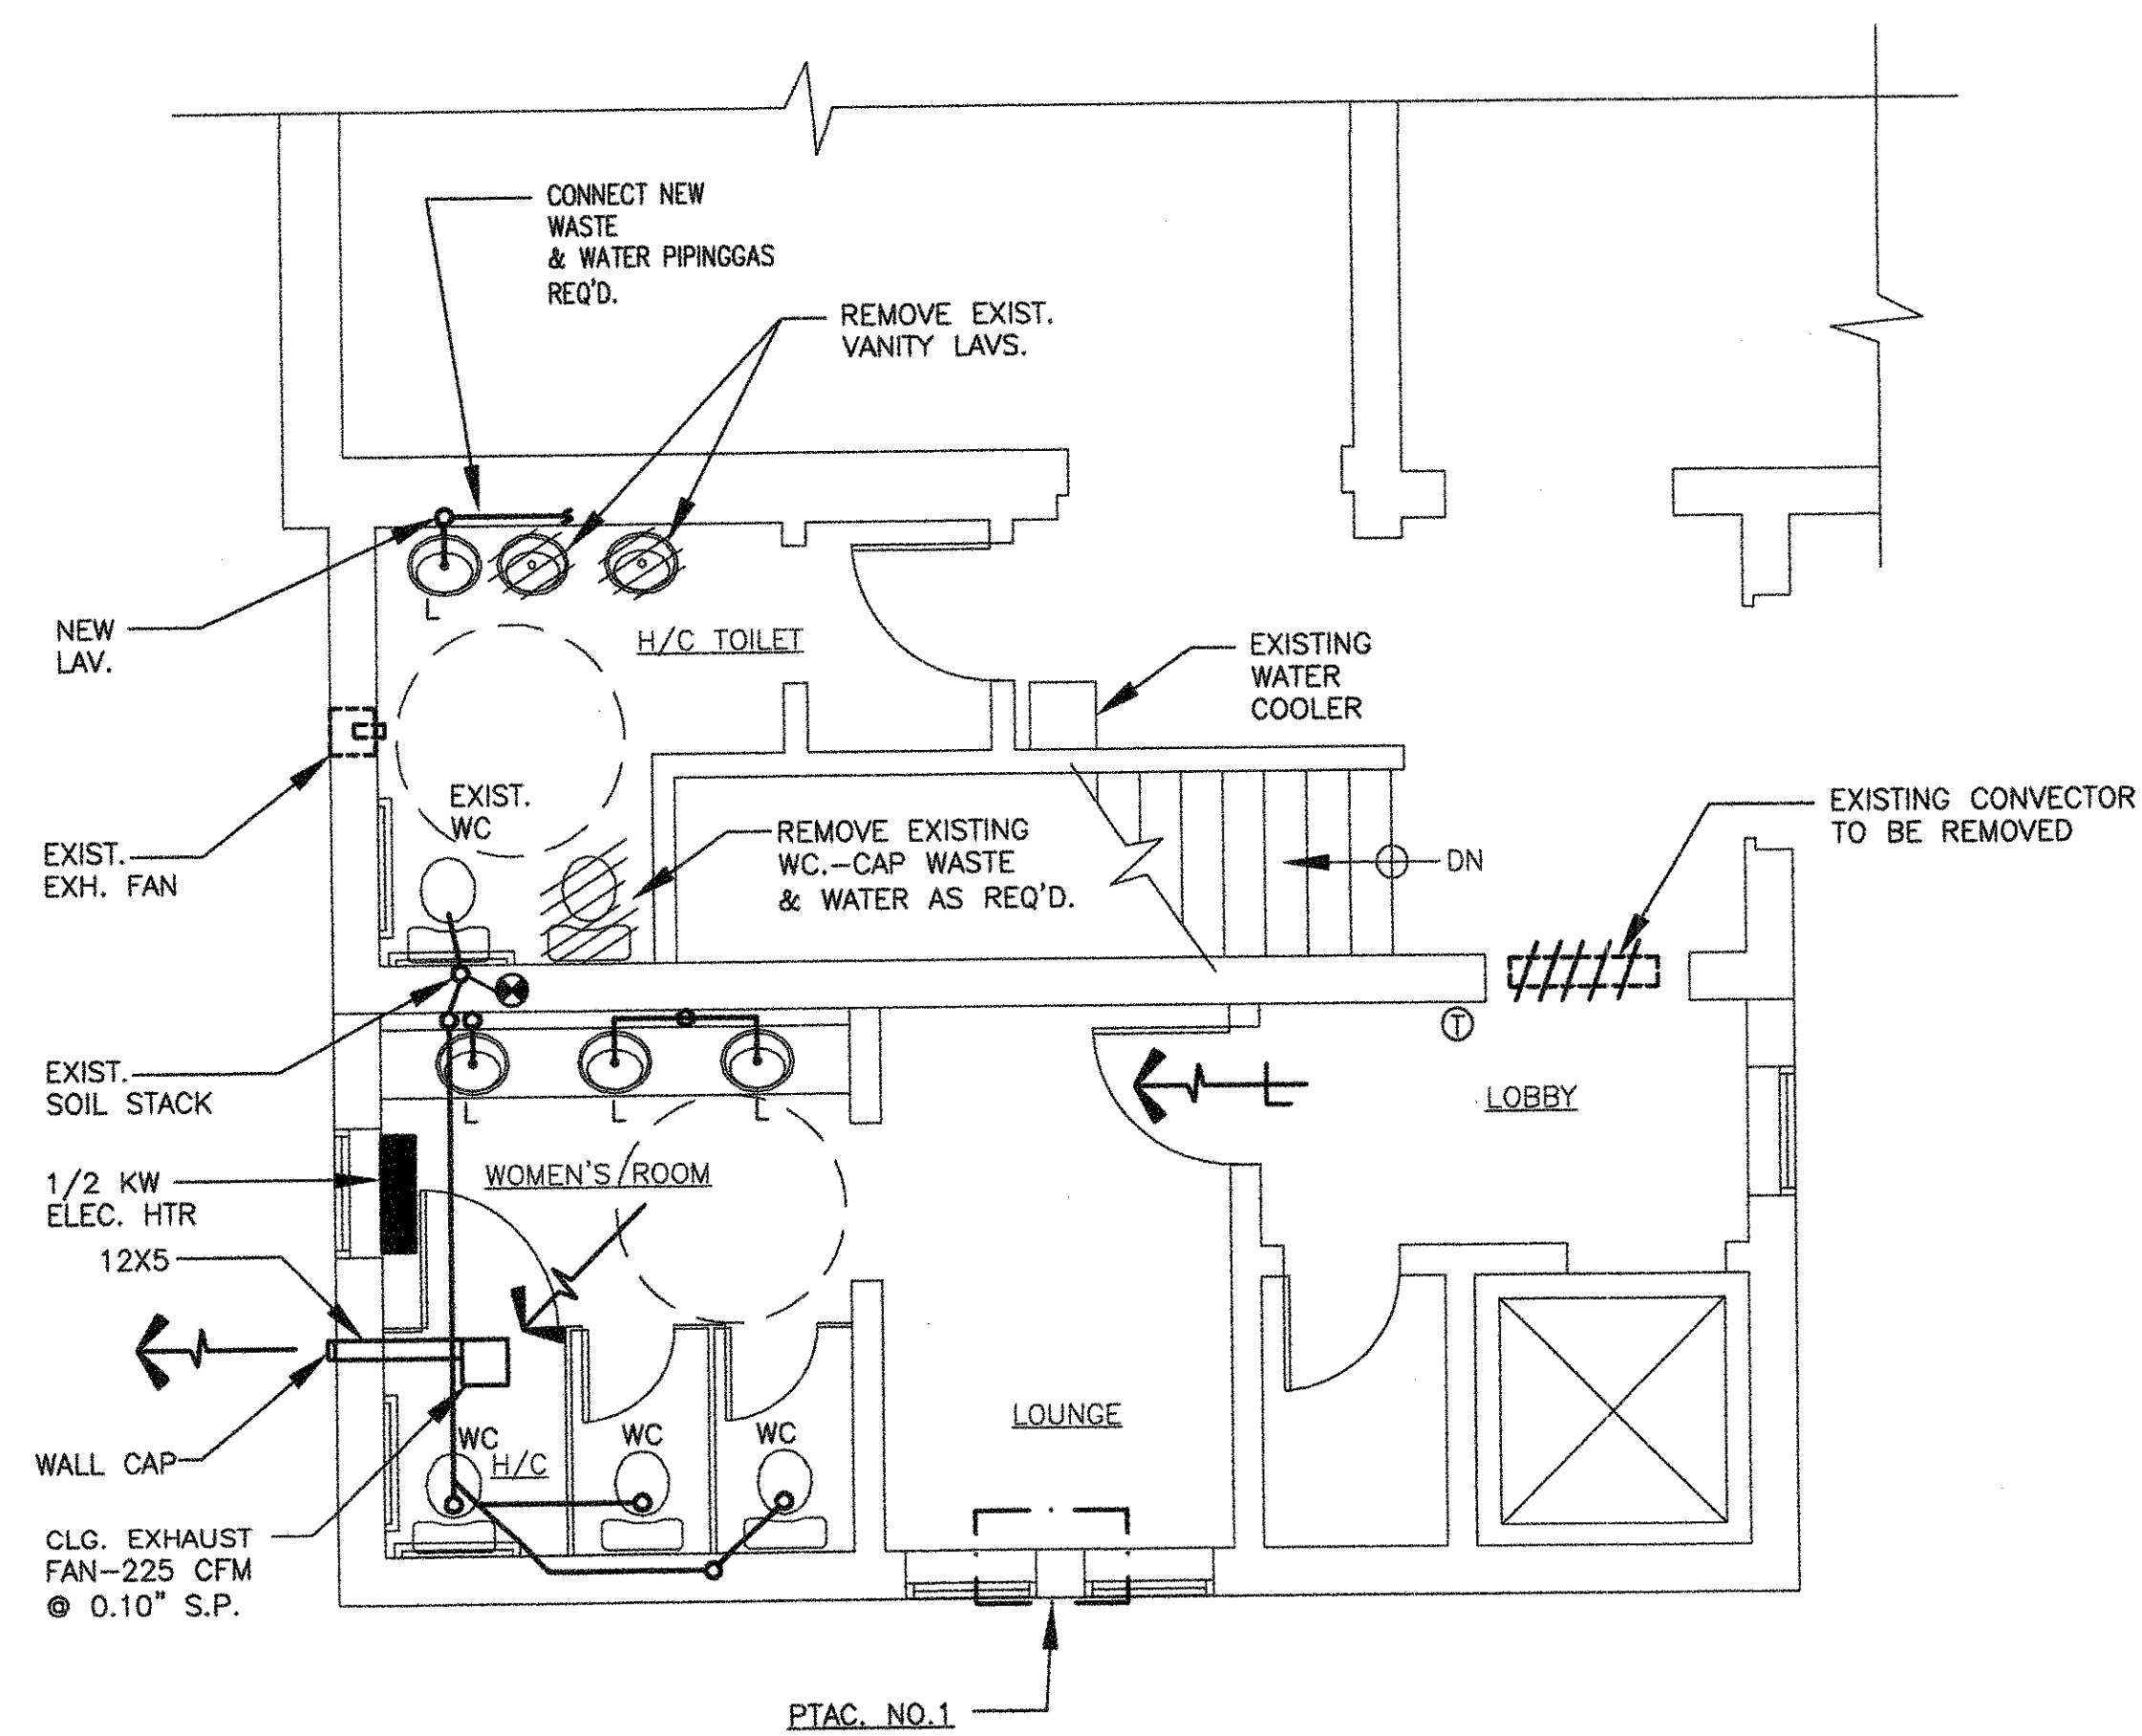

**2** UPPER LEVEL PLAN  
MP.1 SCALE: 1/4" = 1'-0"

**PLUMBING FIXTURE SCHEDULE**


| SYMBOL | FIXTURE      | W      | V      | CW   | HW   | REMARKS     |
|--------|--------------|--------|--------|------|------|-------------|
| WC     | WATER CLOSET | 3"     | -      | 1"   | -    | FLUSH VALVE |
| L      | LAVATORY     | 1 1/2" | 1 1/2" | 1/2" | 1/2" |             |

**PTAC SCHEDULE (HEAT PUMP TYPE)**

| NO. | COOLING CAP. | HEATING CAP. | ELEC. HTR. |
|-----|--------------|--------------|------------|
| 1   | 7.2 MBH      | 6.2 MBH      | 3.4 KW     |

- SYMBOLS**
- EXISTING PIPE
  - SOIL OR WASTE
  - VENT
  - COLD WATER
  - HOT WATER
  - POINT OF CONNECTION-NEW TO EXISTING
  - EXISTING EQUIPMENT TO BE REMOVED

|              |  |
|--------------|--|
| ISSUE DATES: |  |
| REVISIONS:   |  |
| DATE:        |  |

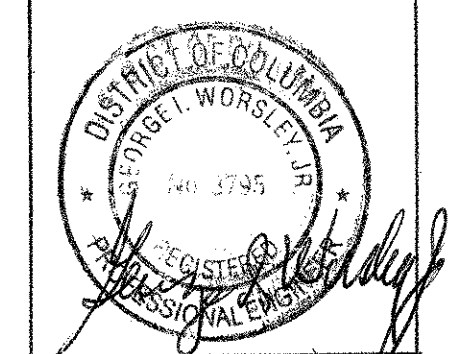

**ST. MARY BAPTIST CHURCH**  
808 EASTERN AVENUE, NW  
WASHINGTON, DC 20012

**ELEVATOR AND RESTROOM ADDITIONS**

|              |  |
|--------------|--|
| DRAWN BY:    |  |
| APPROVED BY: |  |
| SCALE:       |  |
| PROJECT NO.: |  |

**WARDER & ASSOCIATES, INC.**  
CHURCH EXPANSION SPECIALIST  
6018 OLD ALEXANDRIA FERRY RD. CLINTON, MD. 20705

DRAWING NO.  
**MP-1**