
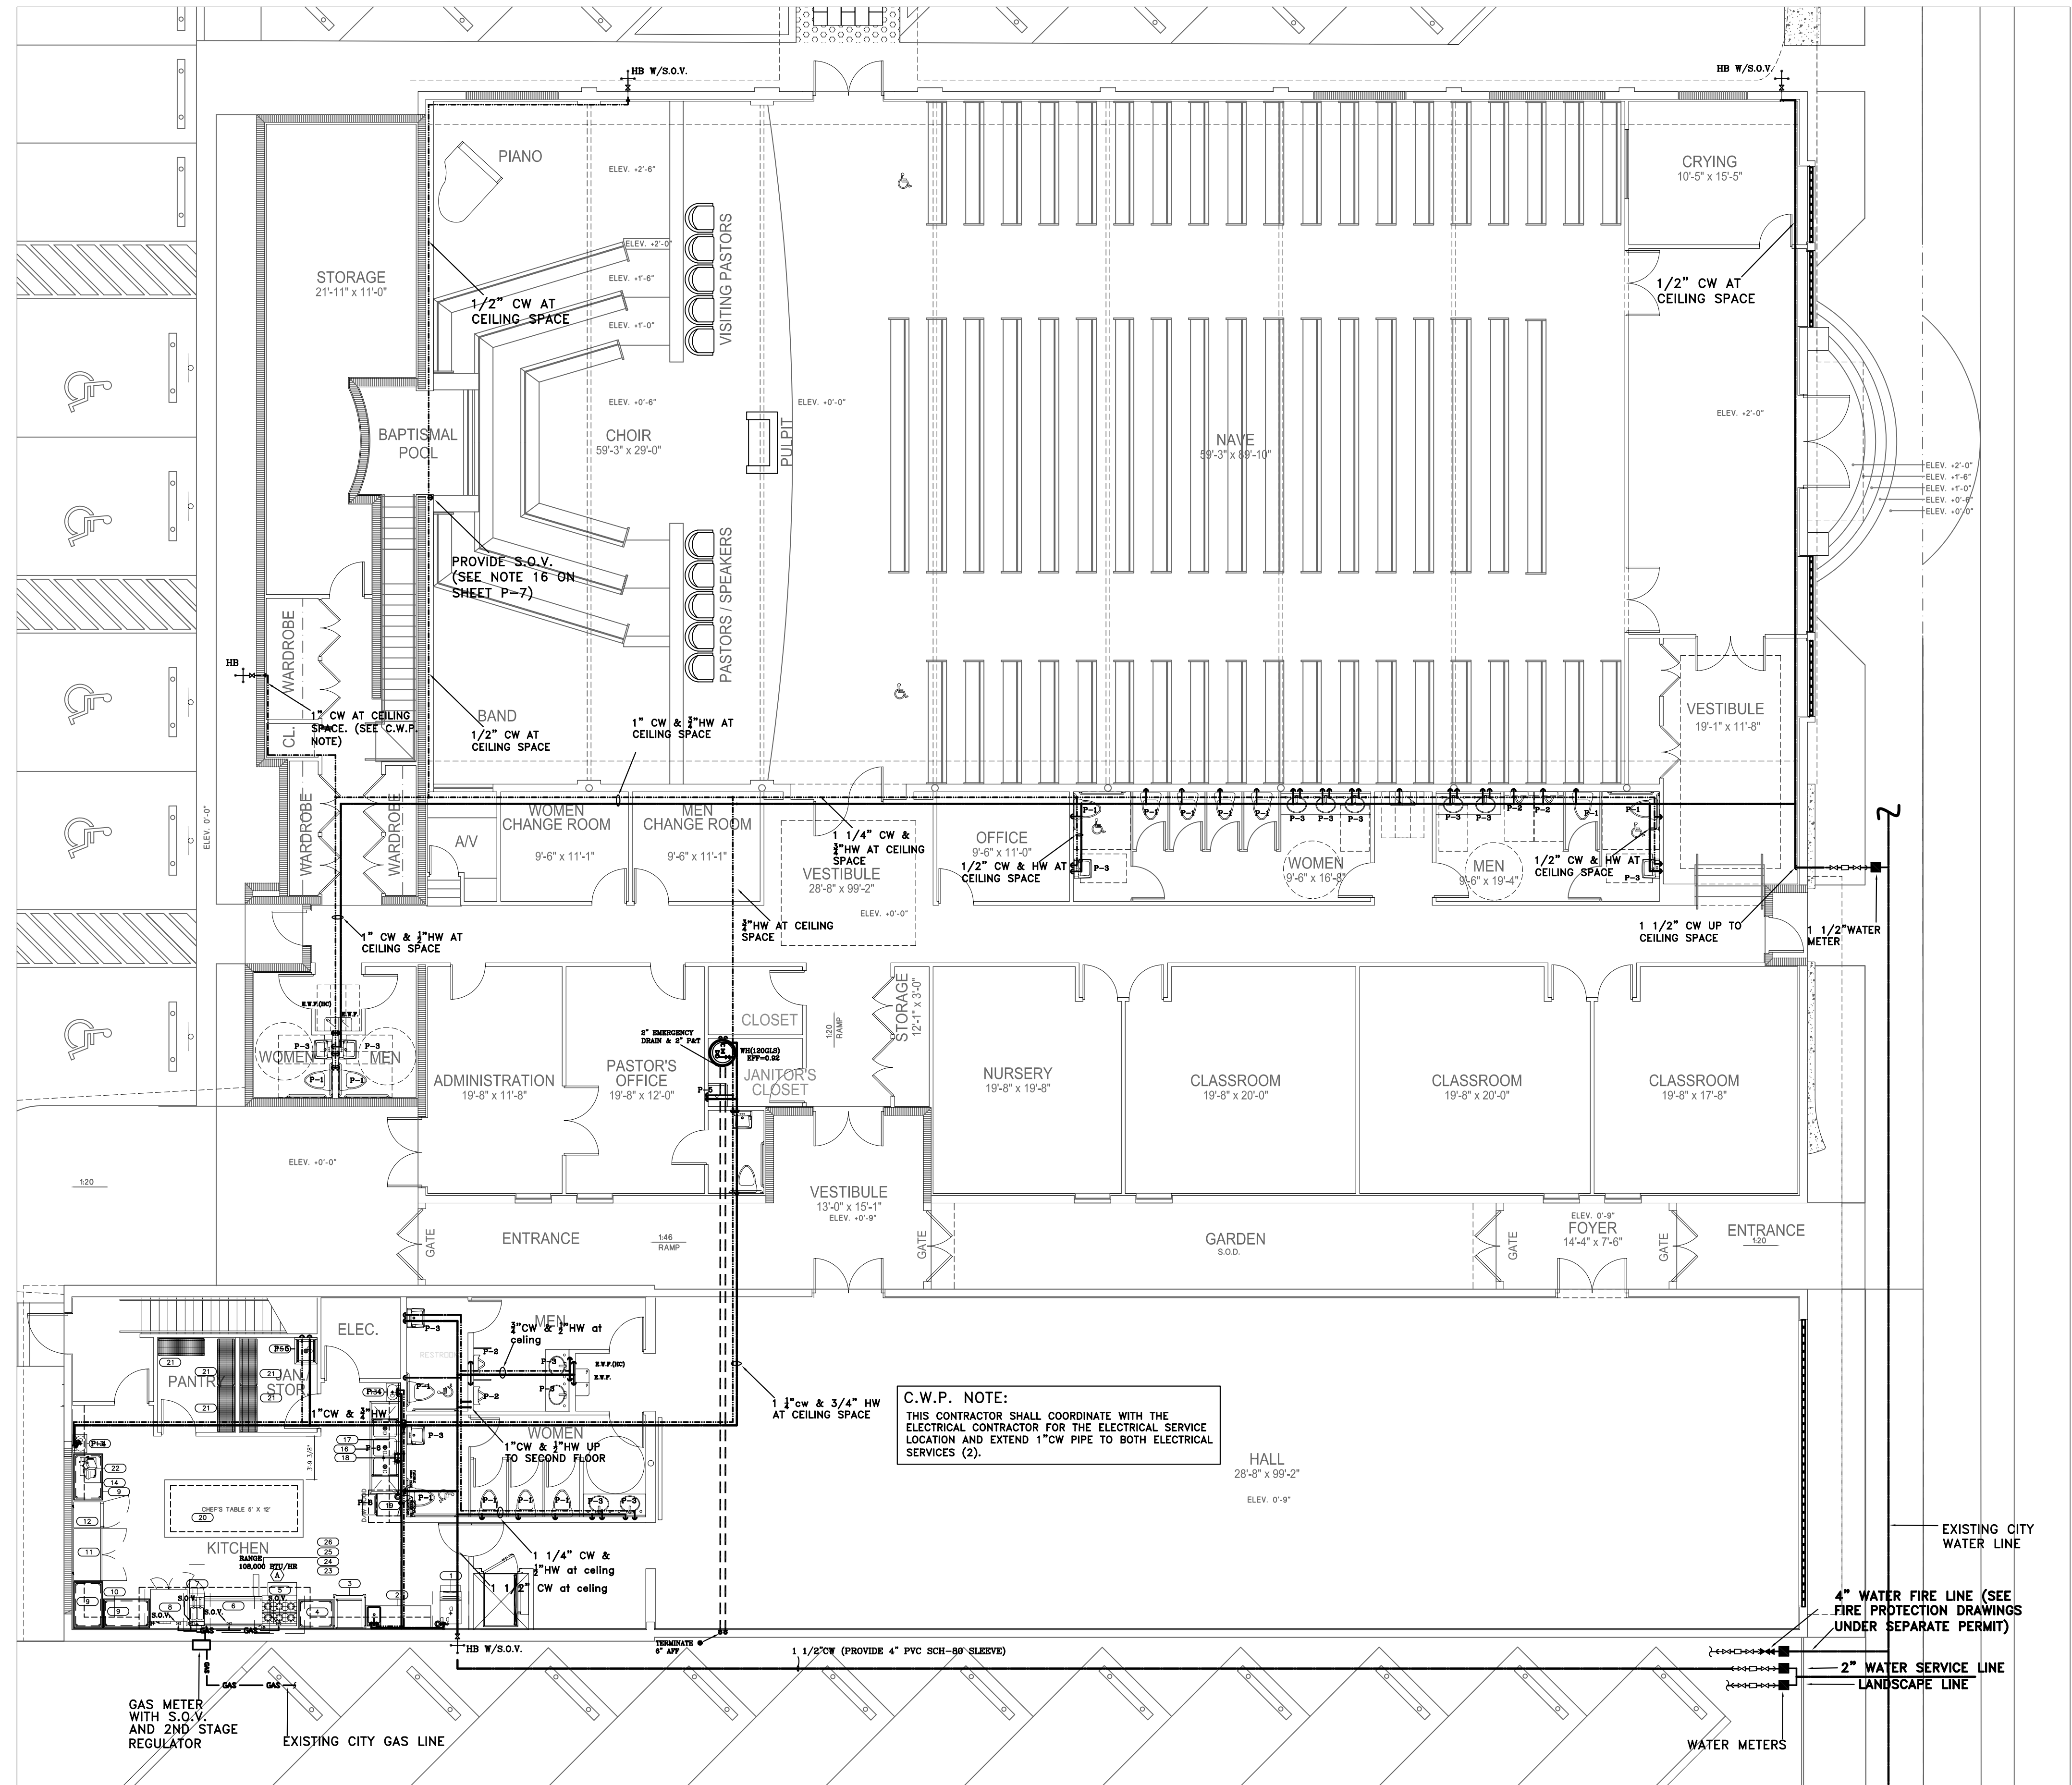


COPYRIGHT - 2008 - RAMOSMARTINEZ architects, inc. All ideas, designs and details indicated or represented by this drawing, created and developed for use on this project, are owned by, and are legal property of RamosMartinez Architects, Inc. Use, reproduction, distribution or alteration is prohibited without written authorization from the Architect.

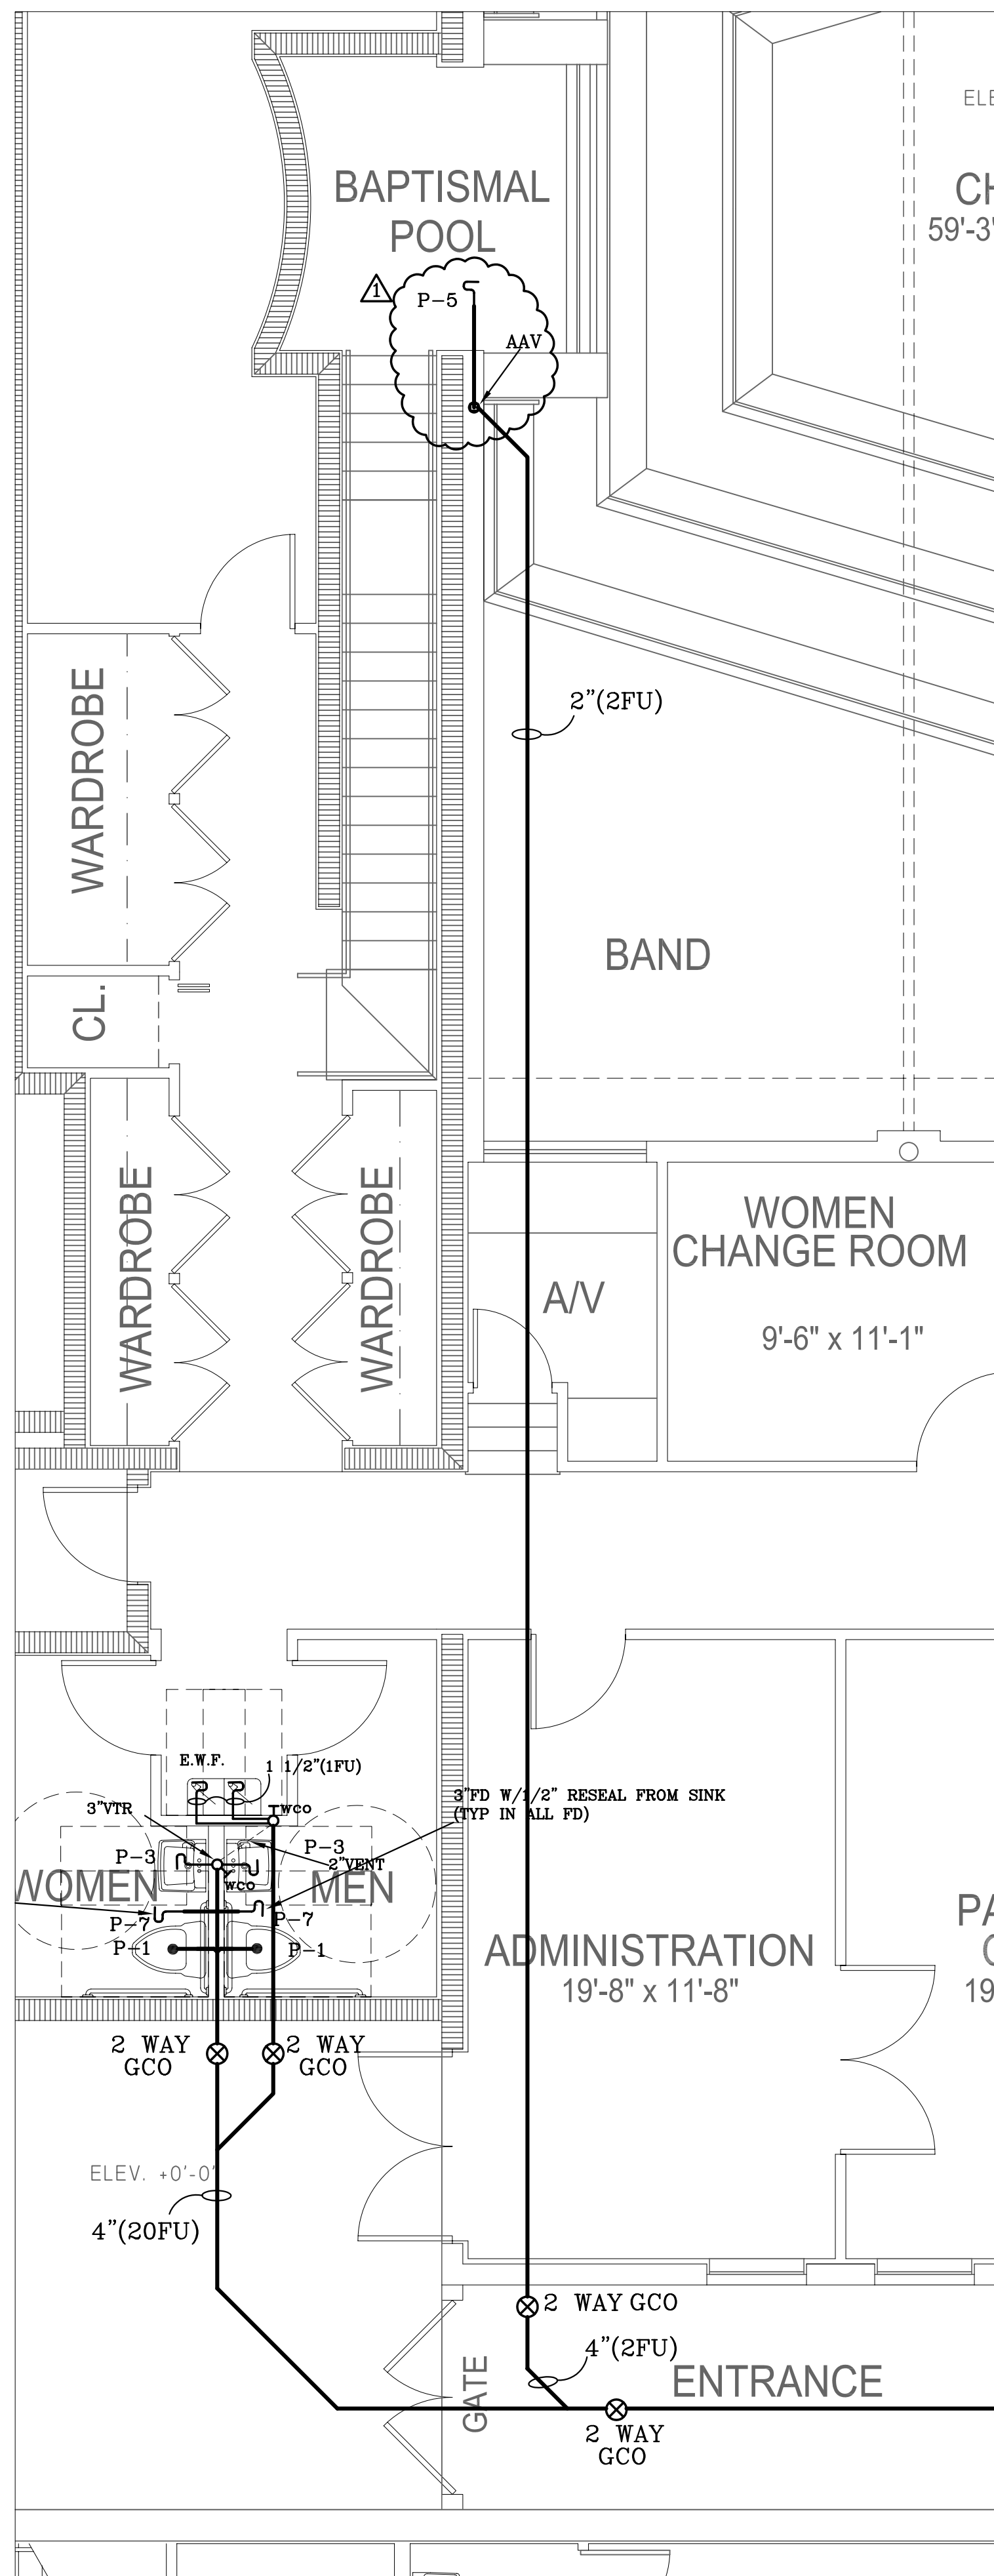

**PLUMBING FLOOR PLAN**

SCALE: 1/8" = 1'-0"

DANIEL F. GUTIERREZ, P.E.  
 LIC. #049086  
 7328 SW 82 ST B-214  
 MIAMI FL 33143  
 PH: (786) 499-4167  
 FAX: (305) 667-5262  
 CELL: 786-499-4167

DESIGN - INSPECTIONS

**RAMOSMARTINEZ**  
 ARCHITECTS  
 P.C.

**First Haitian Free Church of Nazarene by Faith**  
 IN  
 ORLANDO FLORIDA

**FIRST HAITIAN  
 FREE CHURCH  
 OF NAZARENE**

308 SOUTH  
 ORANGE BLOSSOM TRAIL  
 ORLANDO, FLORIDA

REVISIONS:

1 BLDG DEPT COMM 03-26-09

COMM. NO. 08-103

DATE:

DRAWN BY:

CHECKED BY:

P-2

2 OF 7

NEW YORK  
 NEWARK  
 JERSEY CITY, NJ 07302  
 TELEPHONE:  
 FACSIMILE:  
 WEBSITE:  
 MIAMI  
 10th AVENUE  
 MIAMI, FL 33135  
 WWW.RAMOSMARTINEZ.COM  
 305-548-5005  
 305-548-5229