




COPYRIGHT - 2008 - RAMOSMARTINEZ architects, inc. All ideas, designs and details indicated or represented by this drawing, created and developed for use on this project, are owned by, and are legal property of RamosMartinez Architects, Inc. Use, reproduction, distribution or alteration is prohibited without written authorization from the Architect.

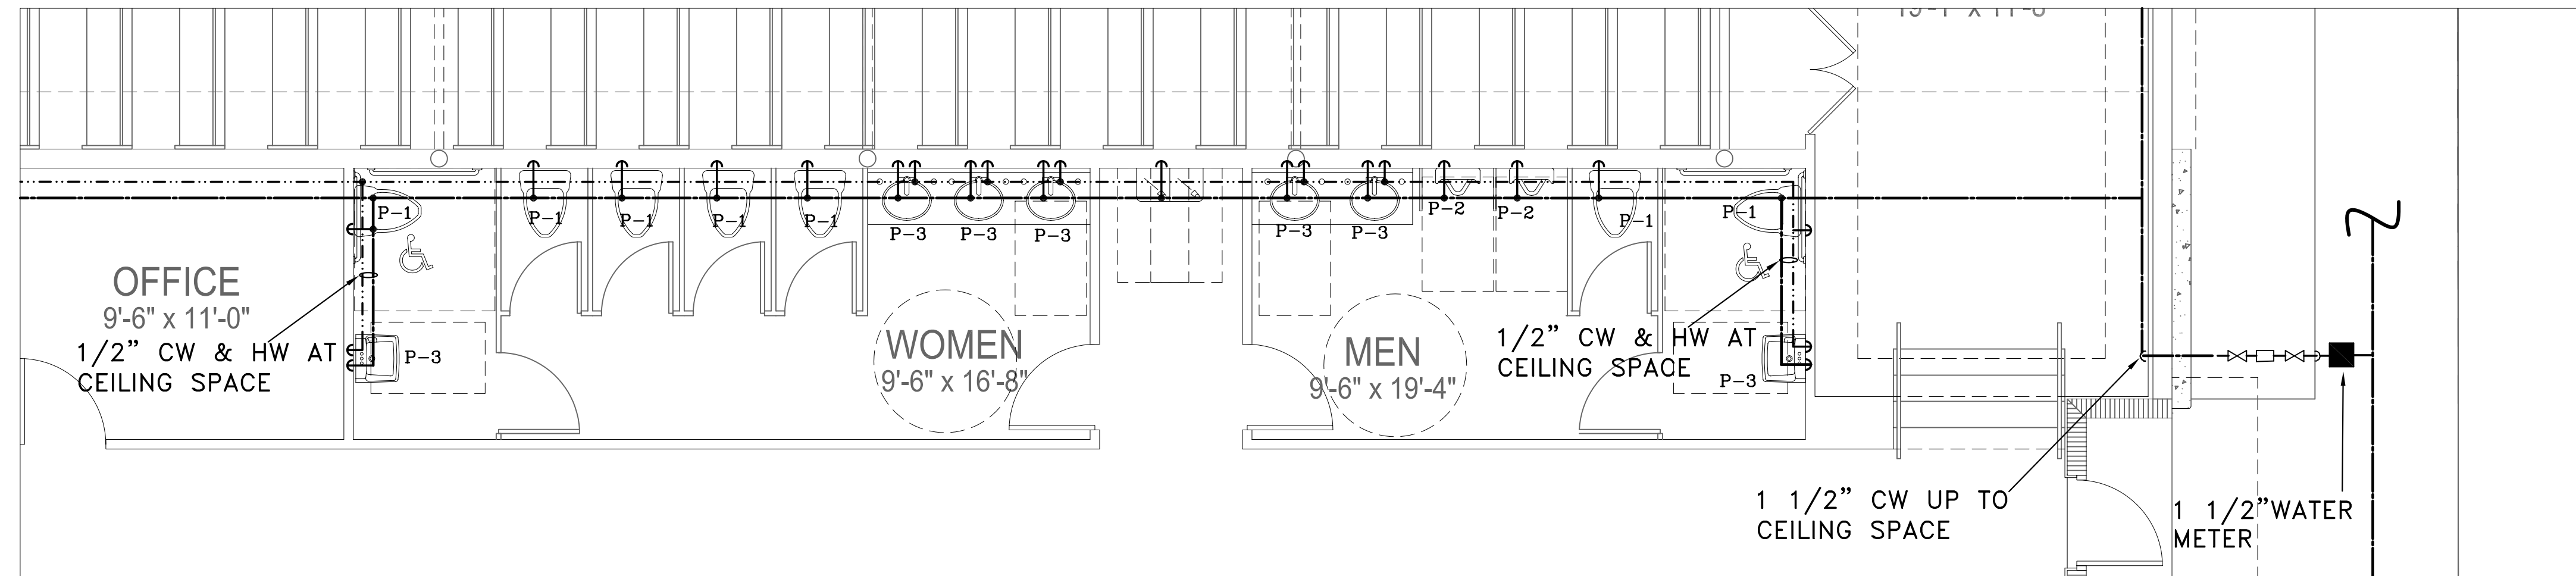

**ENLARGED PLUMBING FLOOR PLAN**  
 SCALE: 1/4" = 1'-0"

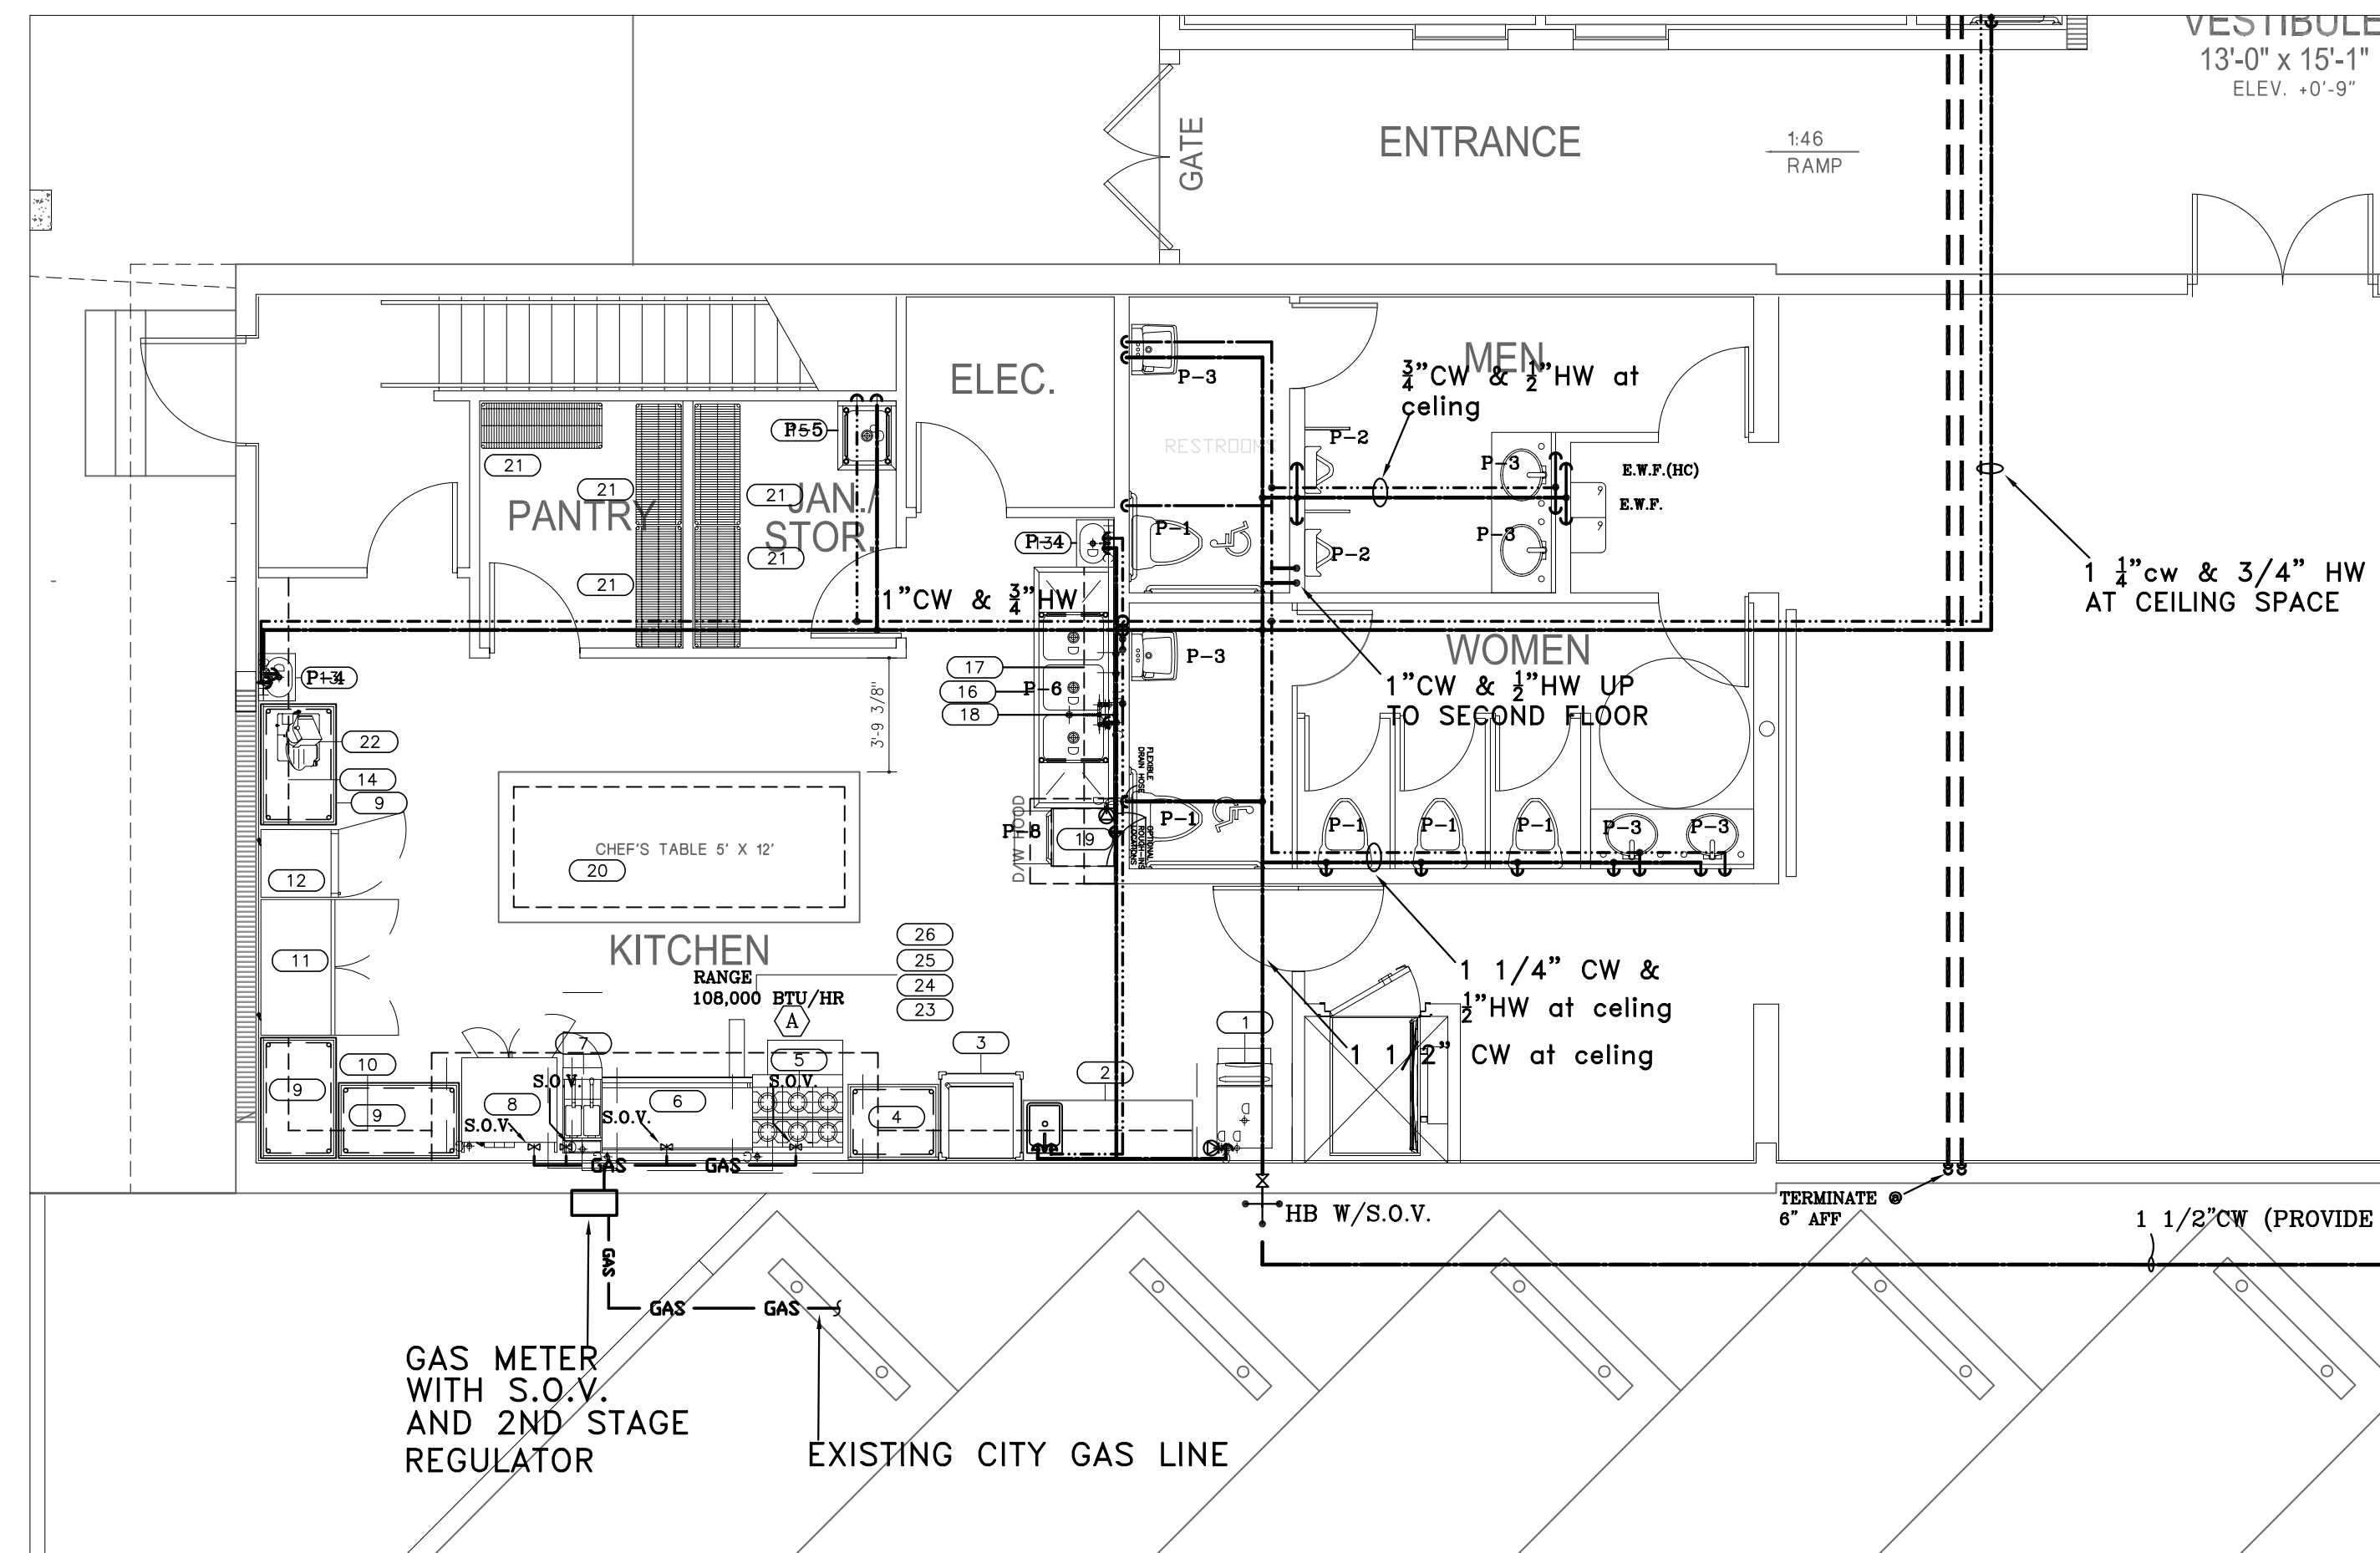

**ENLARGED PLUMBING FLOOR PLAN**  
 SCALE: 3/16" = 1'-0"

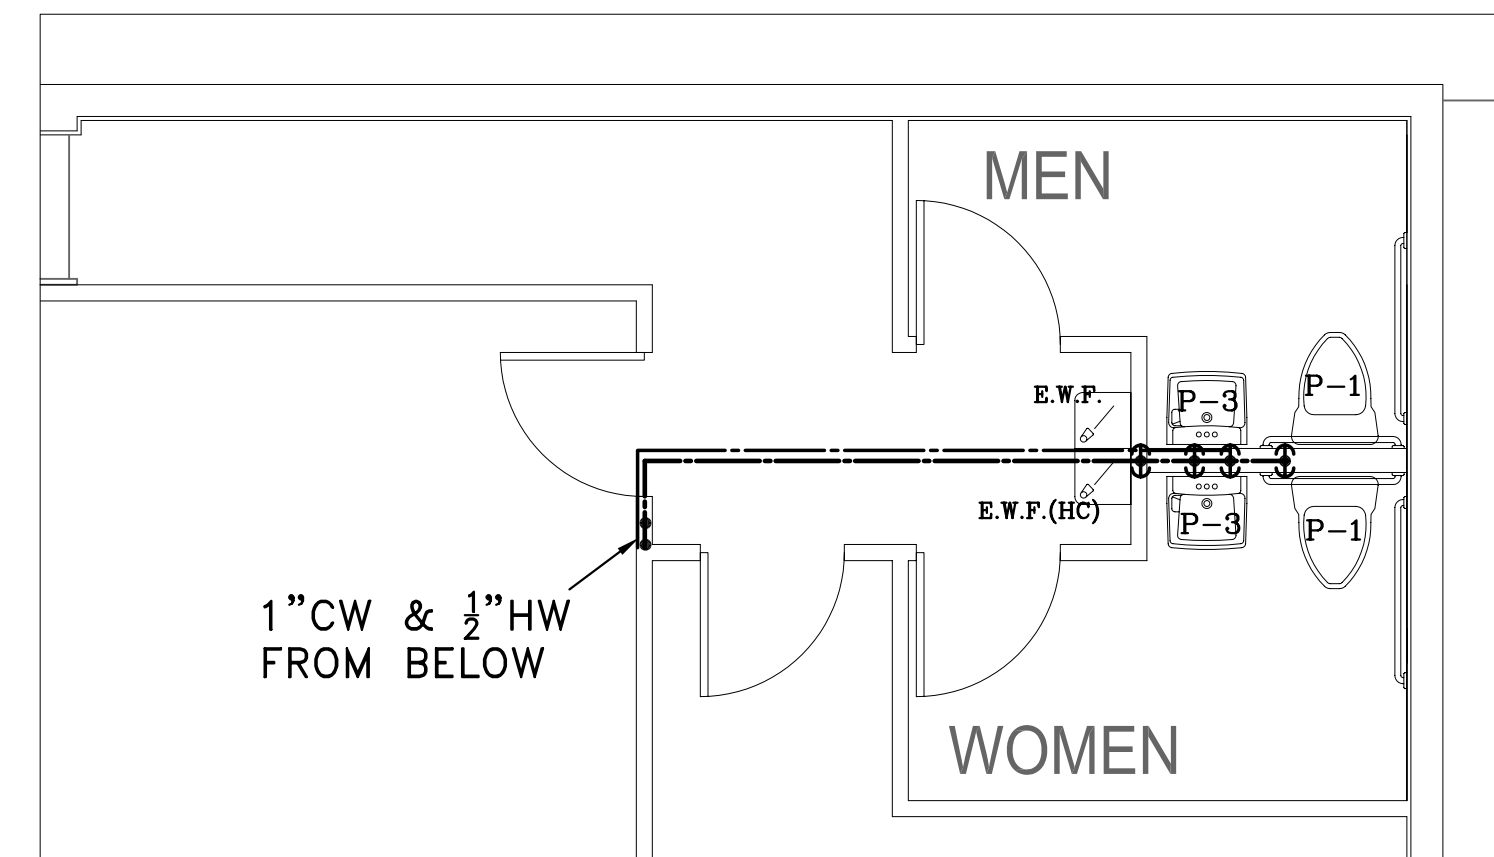

**PLUMBING SECOND FLOOR PLAN**  
 SCALE: 1/4" = 1'-0"

DANIEL F. GUTIERREZ, P.E.  
 LIC. #049086

7328 SW 82 ST. B-214  
 MIAMI FL 33143  
 PH: (786) 499-4167  
 FAX: (305) 867-5262  
 CELL: 786-499-4167

DESIGN - INSPECTIONS

**First Haitian Free Church of Nazarene by Faith**

IN ORLANDO FLORIDA

**FIRST HAITIAN FREE CHURCH OF NAZARENE**

308 SOUTH ORANGE BLOSSOM TRAIL  
 ORLANDO, FLORIDA

REVISIONS:

1 BLDG DEPT COMM  
 03-26-09

COMM. NO. 08-103

DATE:

DRAWN BY:

CHECKED BY:

P-3

3 OF 7

**RAMOSMARTINEZ**  
 ARCHITECTS

NEW YORK  
 NEWARK  
 JERSEY CITY, NJ 07302

MIAMI  
 10th AVENUE  
 MIAMI, FL 33135

305-548-5005  
 305-548-5229  
 www.ramosmartinez.com

TELEPHONE:  
 FACSIMILE:  
 WEBSITE:

985-548-5005  
 305-548-5229  
 www.ramosmartinez.com

AA 26000528